


GEORGE PAVEL
FP DESIGN, LLC

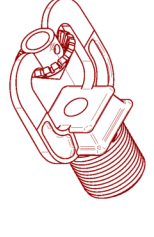

www.paveldesign.com

NICET LEVEL III
Cert. 111693
Professional Engineer
NY License 094583
Certificate of Authorization
NY Certificate 0013922

Professional Engineer
Stamp/Seal and Signature

CONTRACTOR

WATER SUPPLY INFO

Static:
Residual:
Date:
Test Performed by:

0 GP

OUT FOR APPROVALS

No. Date: By:

See Flagged Areas on Plan

PROJECT:

JOB No:


DRAWING TITLE: FIRE PROTECTION - 1st FLOOR

DRAWING

SCALE: 3/16" = 1'-0"

DATE:

DRAWN BY: GP CHECKED BY: GP

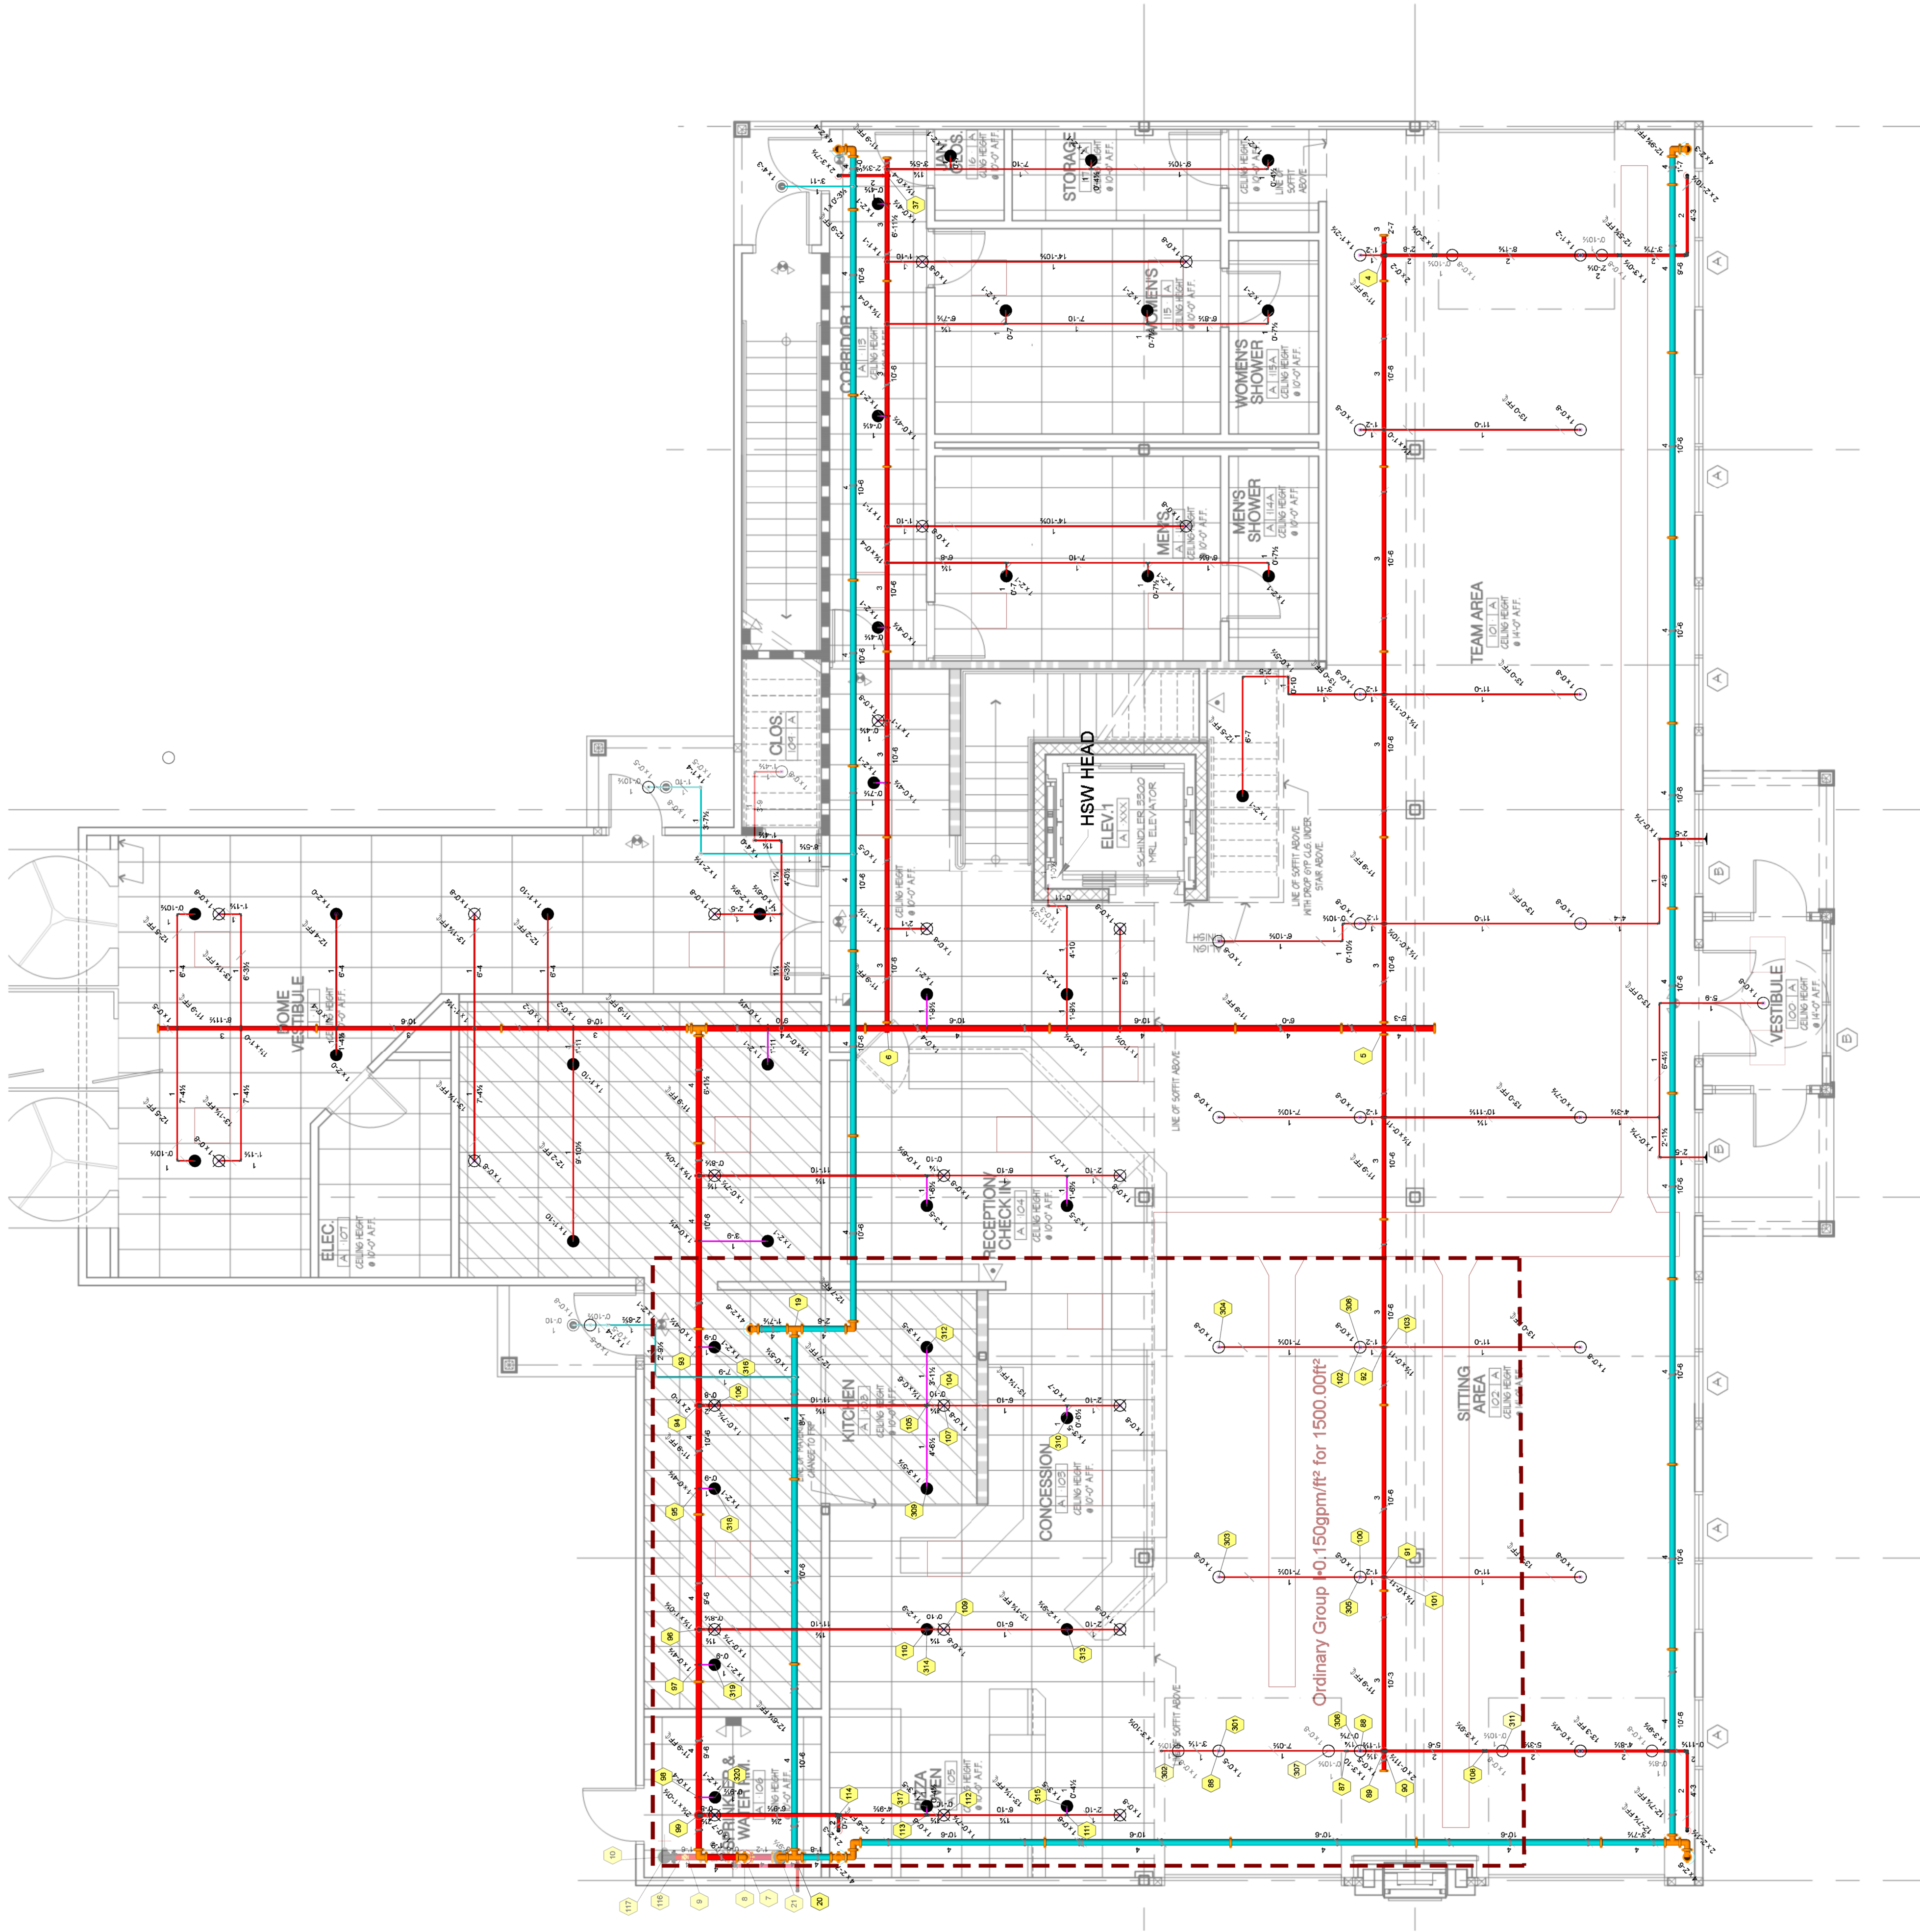

1st FLOOR DESIGN AREA
OH-1, 0.15 GPM / SQ. FT., 1500 SQ. FT.

1st FLOOR FIRE SPRINKLER PLAN
SCALE: 3/16" = 1'-0"